



● Water Bottle Refill Station

● Standard Water Fountain

CLASSROOM
179

OFFICE

LOBBY

LOUNGE

FIRE PUMP

LIVING

STORAGE

ELEV MECH

BOOSTER PUMP

CORRIDOR

ELEC

M
175

MAIN LOUNGE


MECH

DWG. NO. **A-1**
 REVISION DATE: 05-15-2018
 SCALE: N.T.S.
 DESIGN BY:
 BLDG. CODE: 1
 CHECKED BY:

RECORD FLOOR PLAN
 CHESTER HALL BUILDING

FIRST FLOOR PLAN

SA ISBURY UNIVERSITY
 FACILITIES PLANNING & CAPITAL PROJECTS
 ARCHITECTURAL & ENGINEERING SERVICES
 1101 CALVERT AVENUE
 SALISBURY, MARYLAND 21801
 410.543.6215

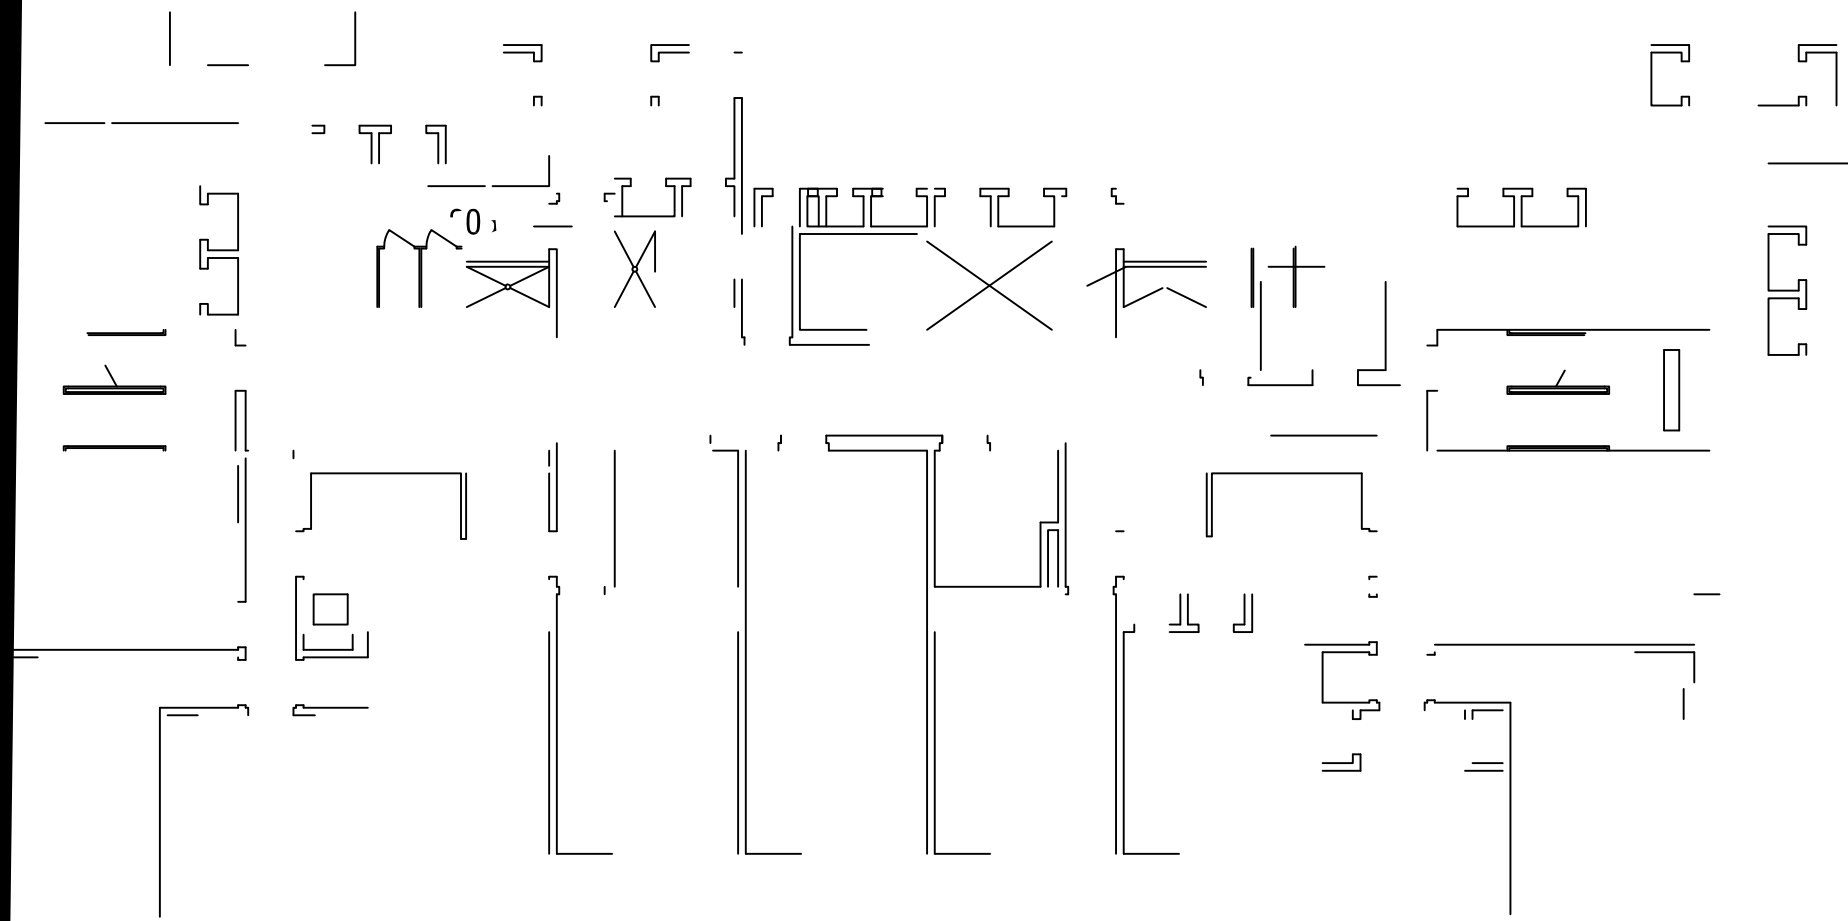


PLA

RECORD FLOOR PLAN
CHESTER HA

PING SERVICES

ND 21

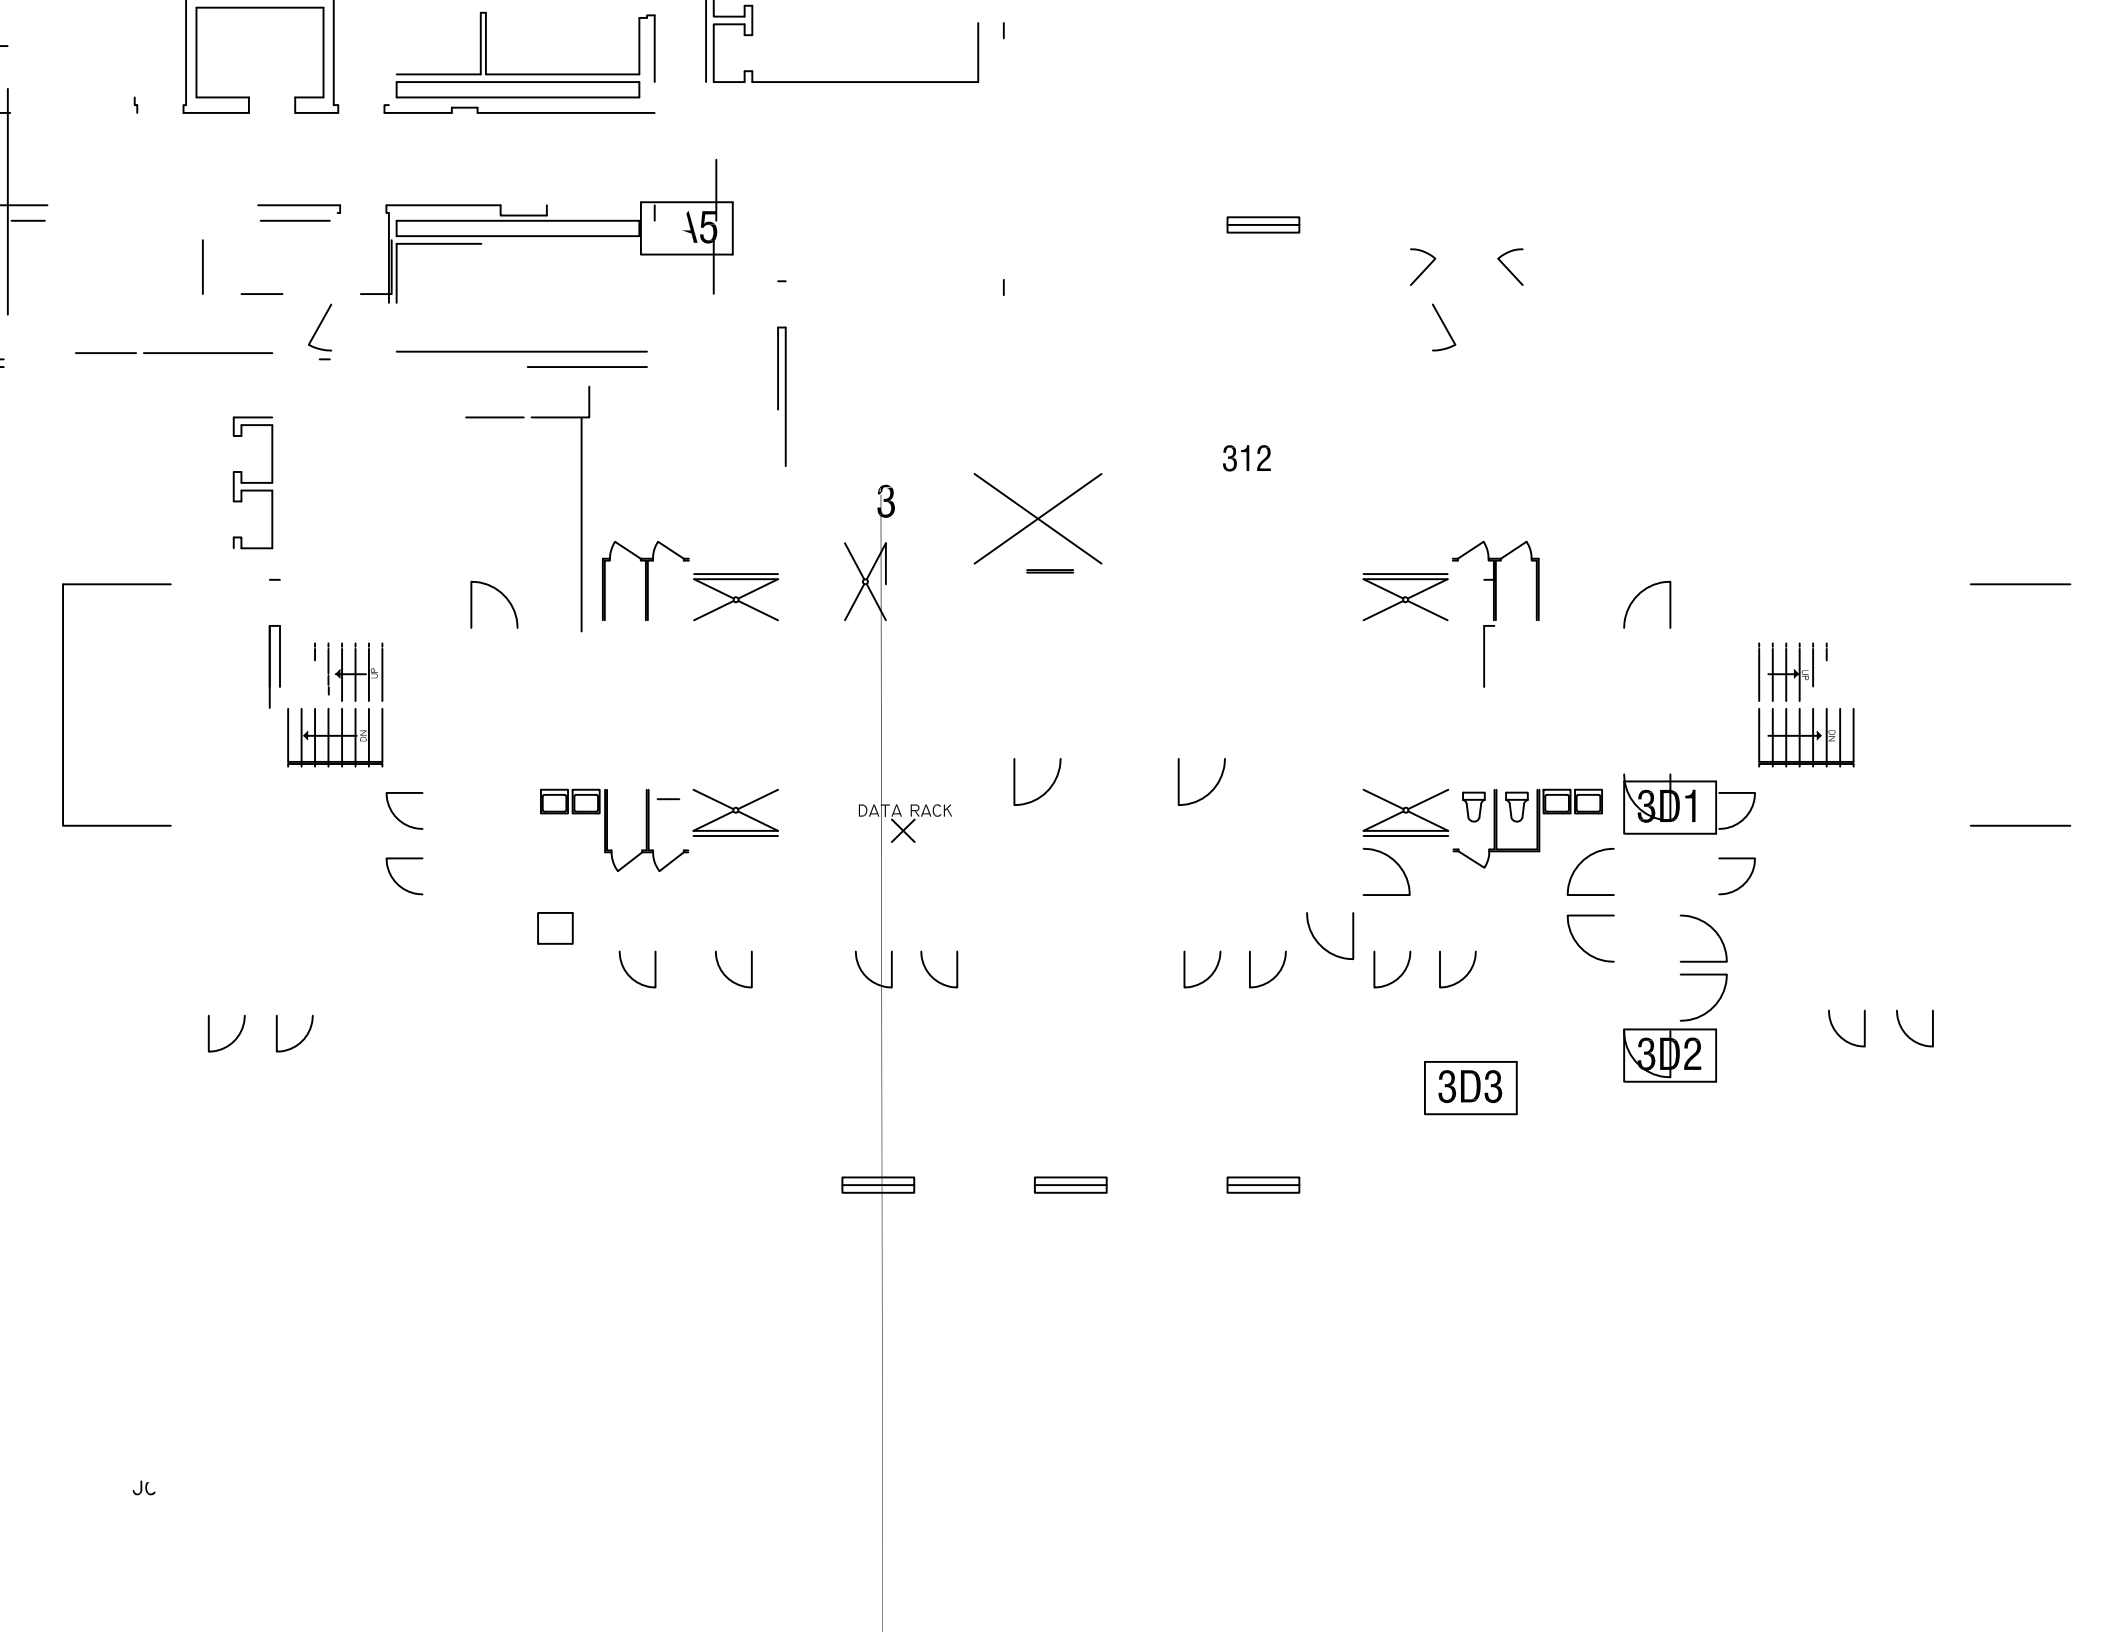

15

312


3

DATA RACK



3D1

3D2


3D3

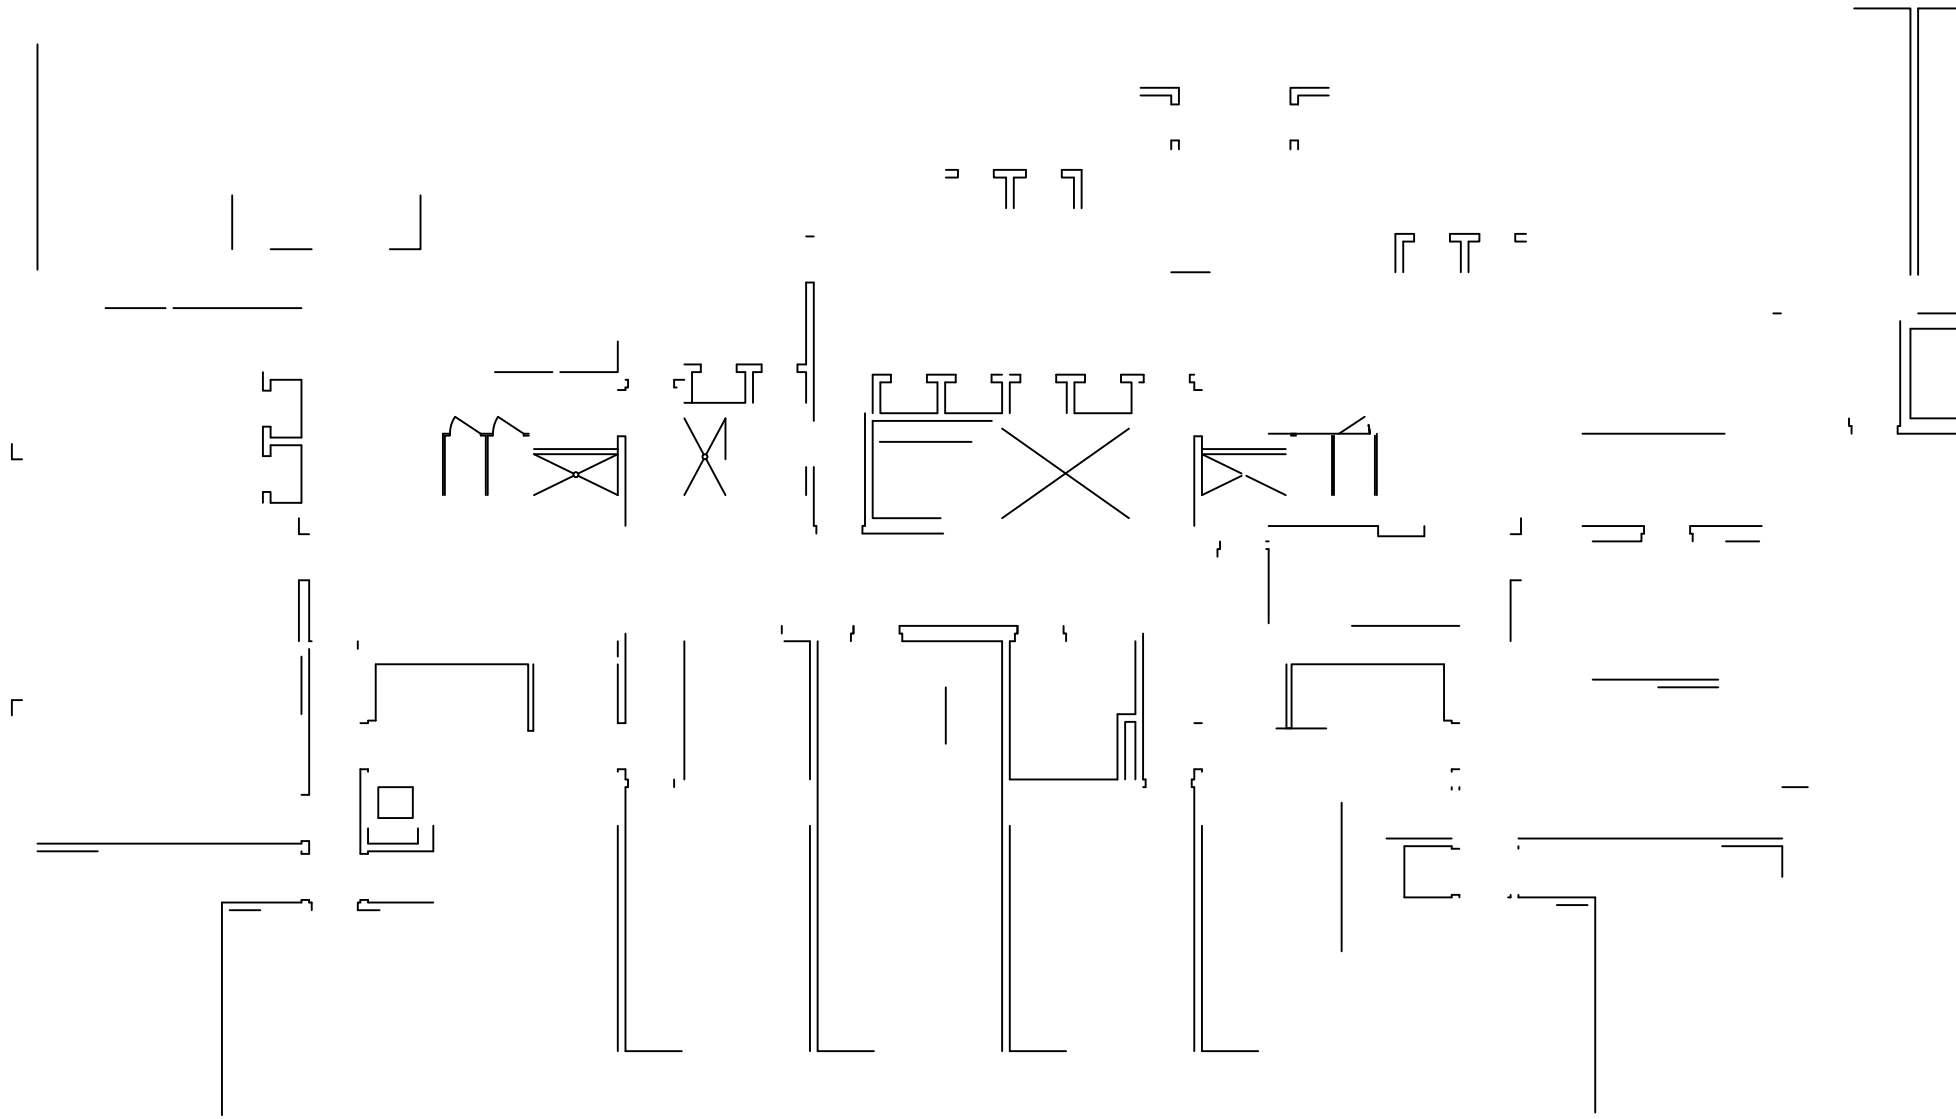






1ST FLOOR PLAN

  

—

 

—

     

—

—