




DWG NO. REVISION DATE  
A-11 08-22-2018

SCALE: N.T.S.

BLDG CODE  
TE





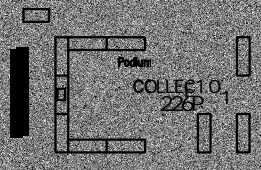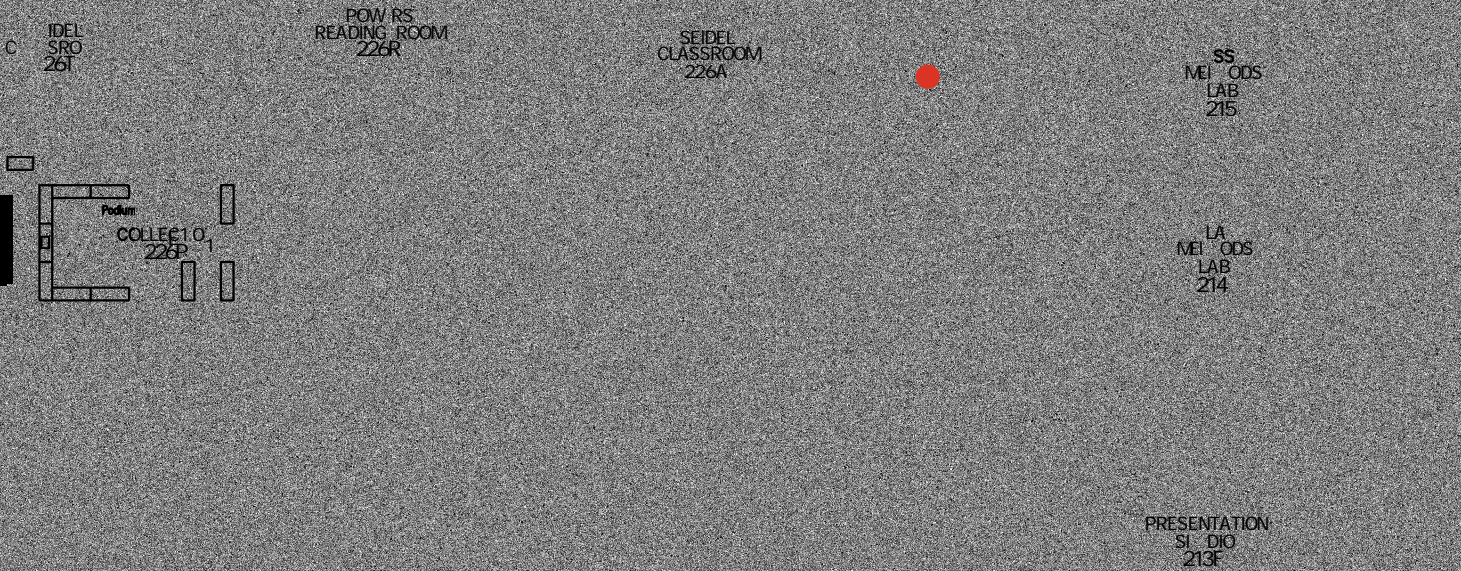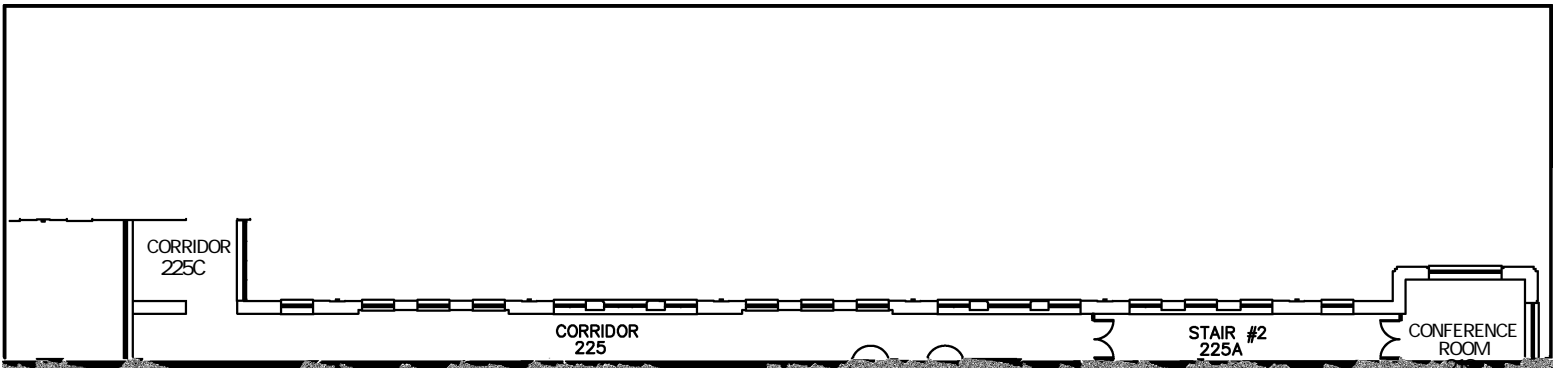

- Water Bottle Refill Station
- Standard Water Fountain

DWG. NO. **A-2.1**  
 REVISION DATE: **08-22-2018**  
 SCALE: **NTS**  
 DESIGN BY: **PLA**  
 BLDG. CODE: **TE**  
 CHECKED BY: **JCD**

**RECORD FLOOR PLAN**  
**CONWAY HALL**  
**SECOND FLOOR PART PLAN**

**SALISBURY UNIVERSITY**  
 FACILITIES PLANNING & CAPITAL PROJECTS  
 ARCHITECTURAL & ENGINEERING SERVICES  
 1101 COLLEGE AVENUE  
 SALISBURY, MARYLAND 21801  
 410.543.6215



WORK ROOM  
254A  
ADMIN-OFFICE  
COMBINATION  
254

ELD  
OFFICE  
254V

SEATED  
253  
200.3

LOUNGE  
250

44 SEAT  
252  
200.3

252A

CORRIDOR

• WO

• TI

-L

-T

-TI

-WO

-M

DWG. NO.: REVISION DATE:

A-2.2

SCALE:

3:5

0.5:1 B 2355:3.4B

BLDG. CODE:

TE

DESIGN BY:

422


CHECKED BY:

..

A0.54.B 2355:3.4B

2-2.42:40.5.22.3:  
EADGELDELDLLOUABEN EIFGEIEELGEIFNLELMGEDLN  
2202BIEEIN AMEILOUEN  
LAI GELCLOULNANNGEIEN 2.2:02N  
420N543N 225N

\_\_\_\_\_

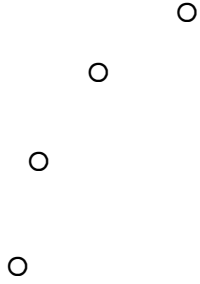

DISTANCE  
LEARNING  
355

OFFICE OF  
THE DEAN  
354



354A

1 ; i \_

RECEIPT ON  
353

PHOTOGRAPHY  
0

5

ù

HY

ING  
J52A

—